


**COMM. ROOM ID 001**

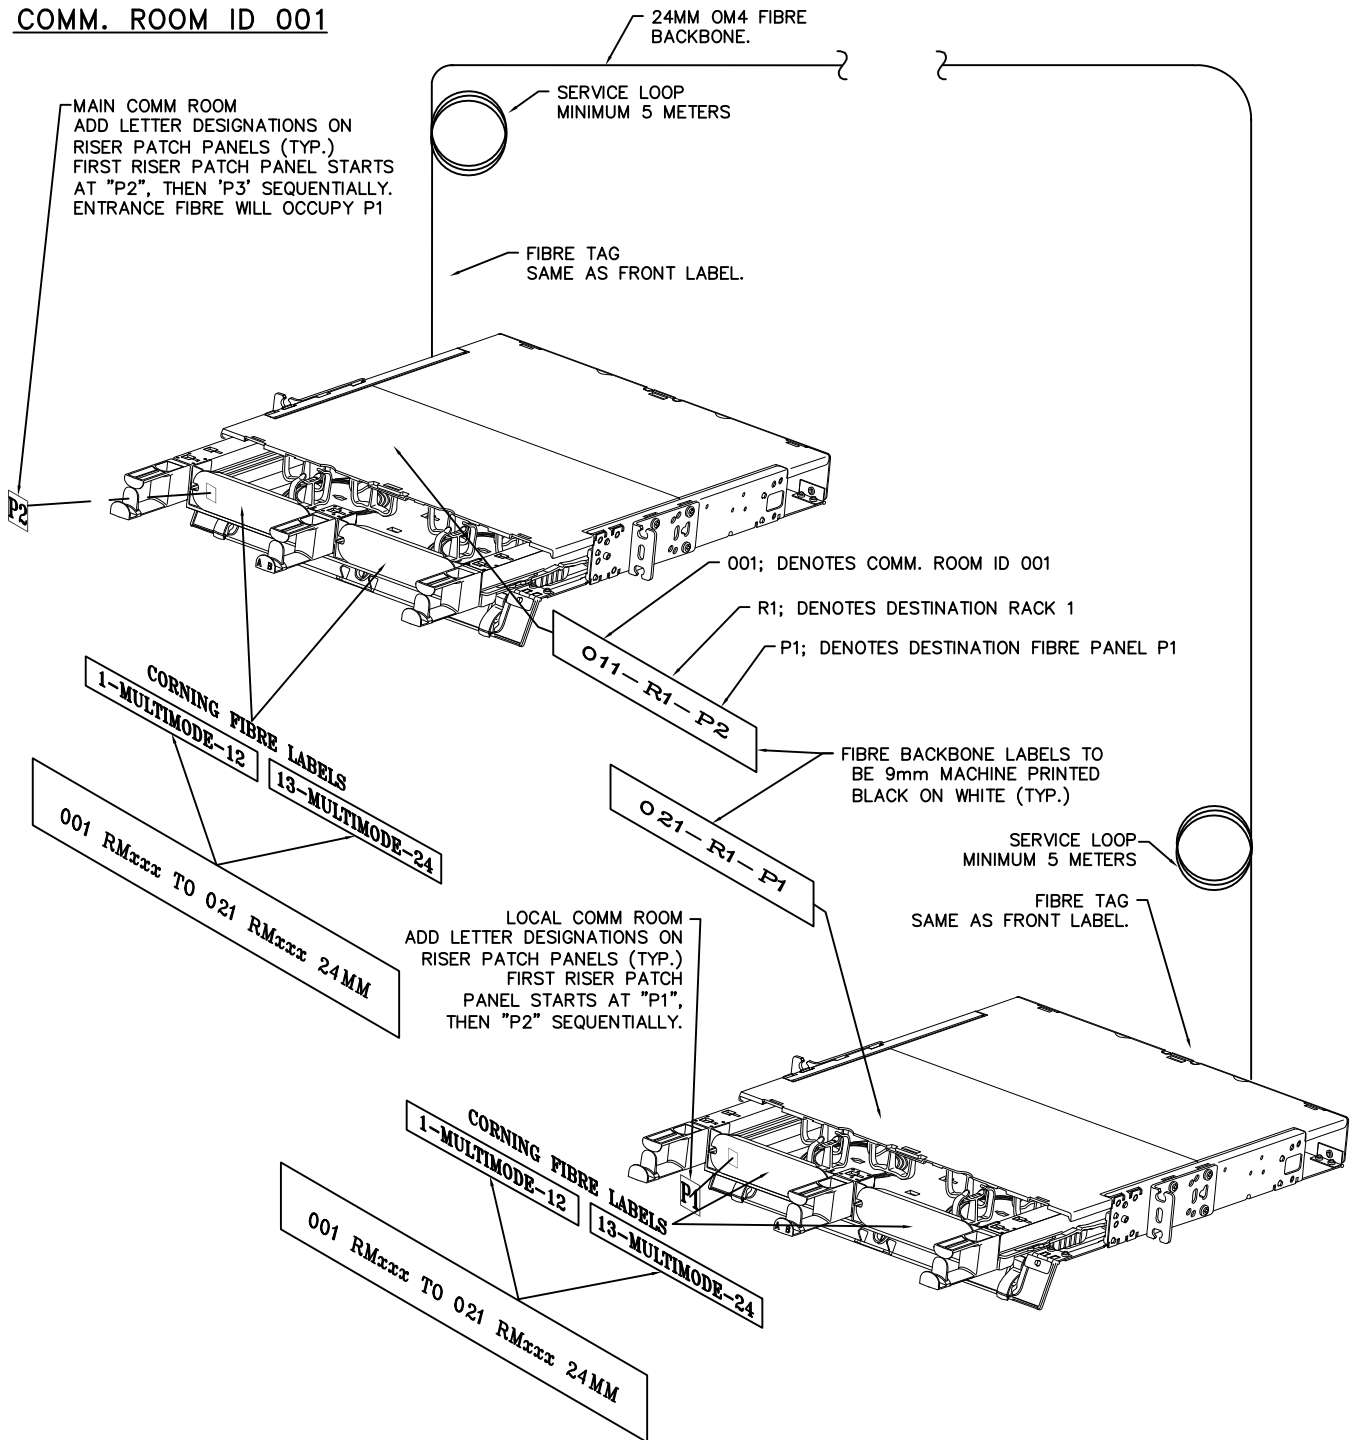

No.	BY	DATE	REVISIONS	App'd
Scale	NONE			
Sheet No.	1 of 1		Drawn	MET 05 MAR 04
UBC Project No.	Check'd	TZ	5 FEB 14	
	Design'd			
	Approv'd	B. MACDONALD-RCDD	15 FEB 14	

Building/Facility Name

## COMMUNICATIONS RISER FIBRE BACKBONE DETAILS

This drawing and its contents are confidential, and are for the private information of the Client Name. It is not to be relied upon or used in whole or in part for other purposes or by or for the benefit of others without prior adaptation and specific written verification by UBC, Information Technology.

UNIVERSITY OF BRITISH COLUMBIA

File No. ITSTD-63

Rev. 1